









PRELIMINARY REVIEW DRAFT ONLY			
NO.	DATE	REVISION/ISSUE	BY
SHEET TITLE <b>CONCEPTUAL SITE PLAN - CHURCH STREET - SHEET 2</b>			
PROJECT TITLE <b>LENOX VILLAGE SEWER IMPROVEMENTS</b> Church Street, Housatonic Street & Franklin Street Lenox, MA		PROJECT NO. <b>E3089</b> SCALE <b>1"=10'</b> DATE <b>10/27/2023</b> DESIGNED BY <b>MAL</b> DRAWN BY <b>MAL</b> CHECKED BY	
FORESIGHT LAND SERVICES		ENGINEERING SURVEYING PLANNING FORESIGHT LAND SERVICES, INC. 1496 WEST HOUSATONIC STREET - PITTSFIELD, MA 01201 TEL (413) 499-1560 FAX (413) 499-3307 WWW.FORESIGHTLAND.COM	
SHEET NO. <b>SP-1.1</b>		OF _____ SHEETS E3089001	



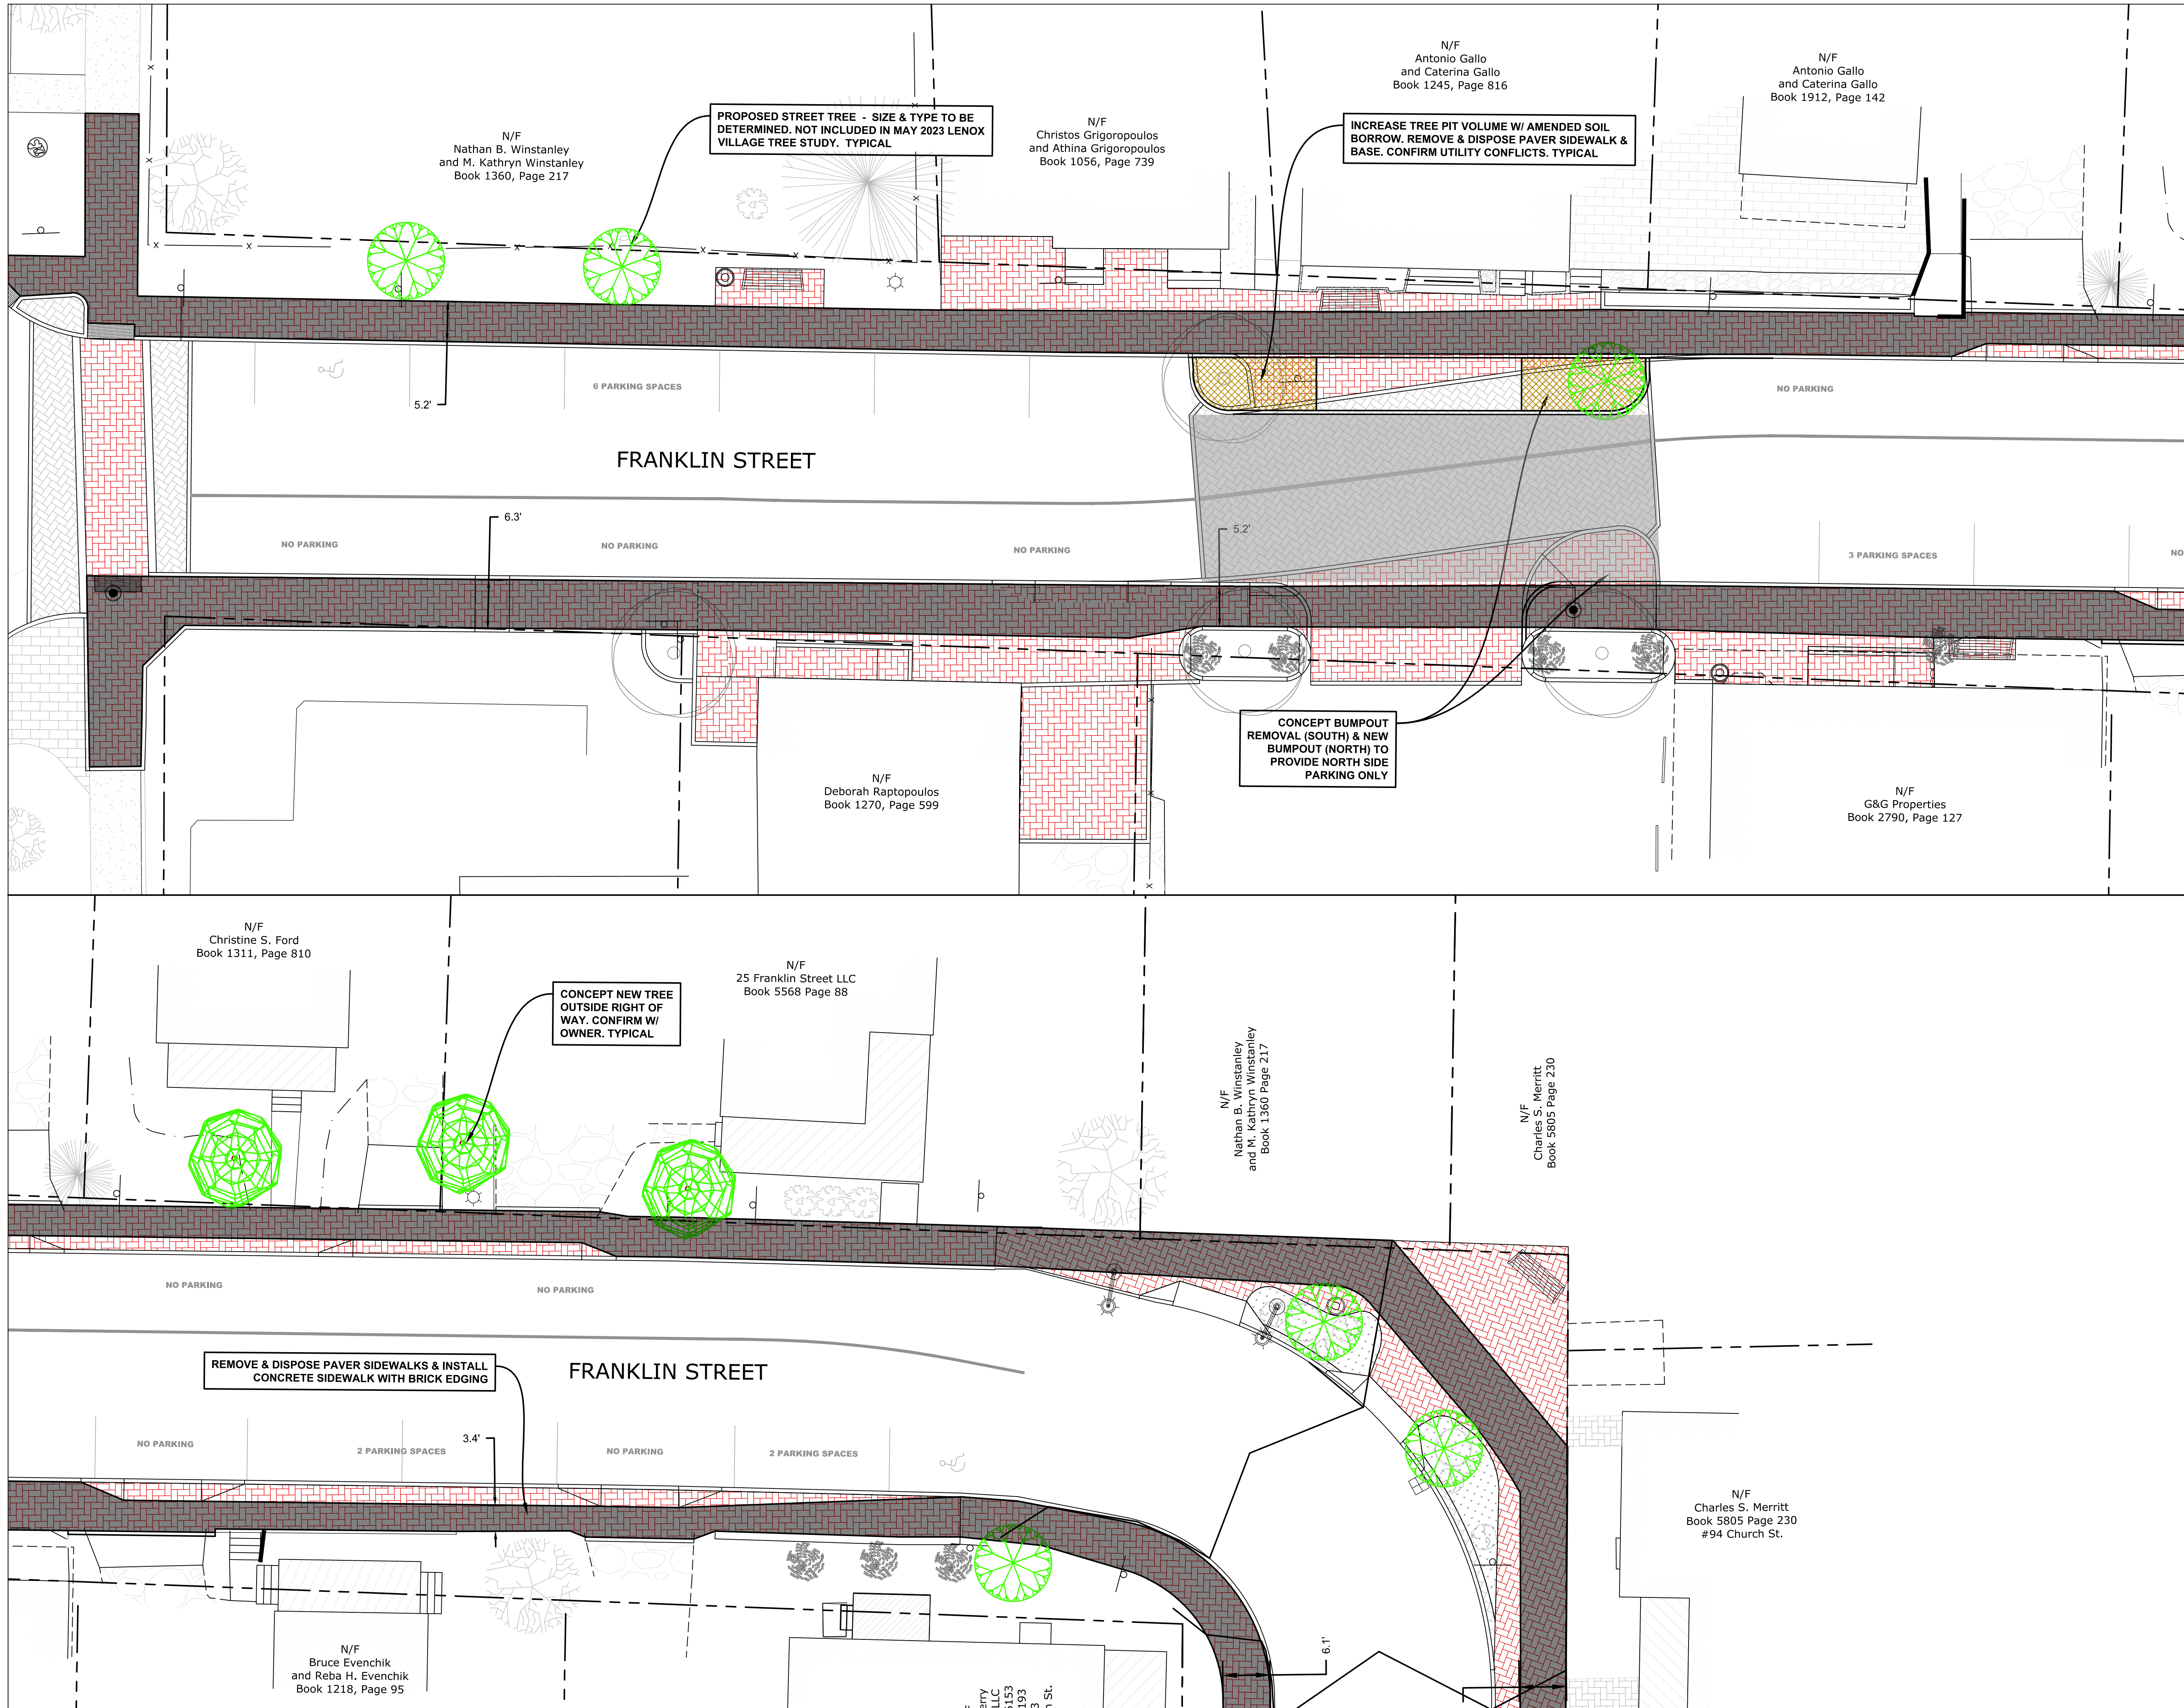

PRELIMINARY REVIEW DRAFT ONLY			
NO.	DATE	REVISION/ISSUE	BY
SHEET TITLE		PROJECT NO. E3089	
CONCEPTUAL SITE PLAN -FRANKLIN STREET		SCALE 1"=10'	
DATE 10/27/2023		DESIGNED BY MAL	
PROJECT TITLE		DRAWN BY MAL	
LENOX VILLAGE SEWER IMPROVEMENTS		CHECKED BY	
Church Street, Housatonic Street & Franklin Street Lenox, MA		SHEET NO. SP-2.0	
FORESIGHT LAND SERVICES		OF SHEETS	
ENGINEERING SURVEYING PLANNING		DRAWN NO. E3089001	
FORESIGHT LAND SERVICES, INC. 1496 WEST HOUSATONIC STREET - PITTSFIELD, MA 01201 TEL (413) 499-1560 FAX (413) 499-3307 WWW.FORESIGHTLAND.COM			



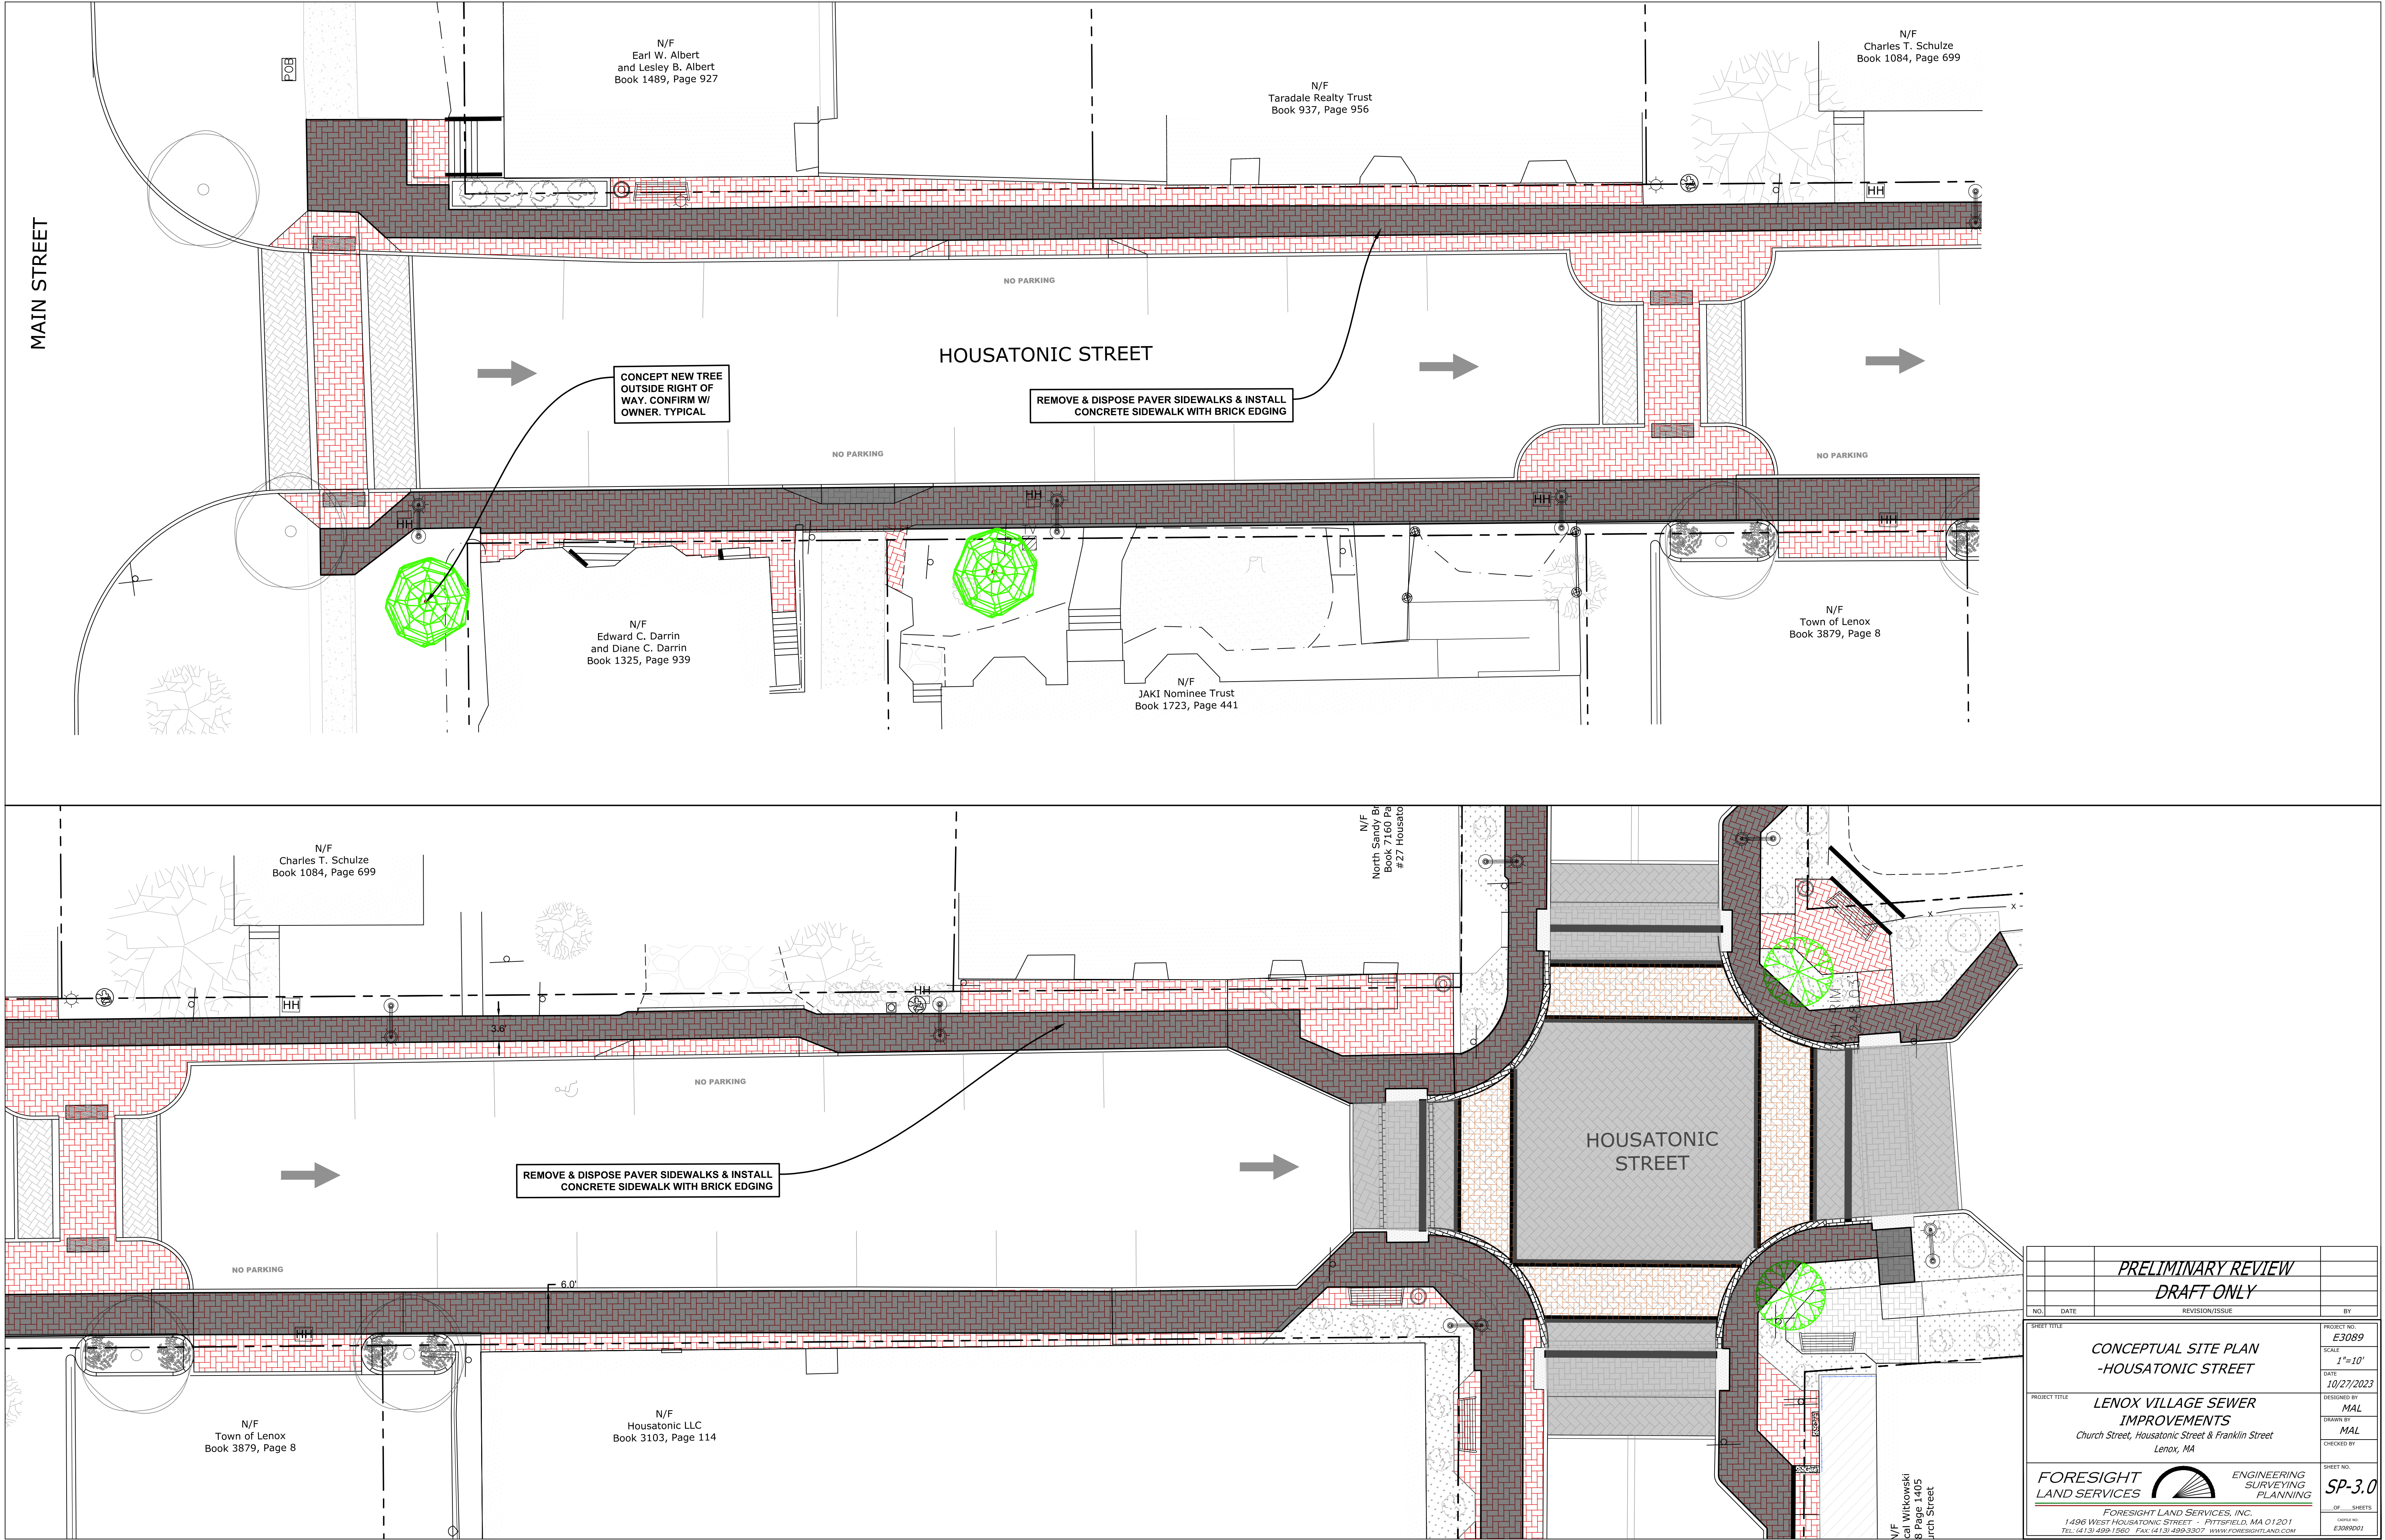

PRELIMINARY REVIEW DRAFT ONLY			
NO.	DATE	REVISION/ISSUE	BY
SHEET TITLE			
CONCEPTUAL SITE PLAN -HOUSATONIC STREET			
PROJECT TITLE			
LENEX VILLAGE SEWER IMPROVEMENTS Church Street, Housatonic Street & Franklin Street Lenox, MA			
PROJECT NO. E3089			
SCALE 1"=10'			
DATE 10/27/2023			
DESIGNED BY MAL			
DRAWN BY MAL			
CHECKED BY			
SHEET NO. SP-3.0			
OF SHEETS			
FORESIGHT LAND SERVICES, INC. 1496 WEST HOUSATONIC STREET - PITTSFIELD, MA 01201 TEL (413) 499-1560 FAX (413) 499-3307 WWW.FORESIGHTLAND.COM			
ENGINEERING SURVEYING PLANNING			